

Notes

Revision

File Name: 000048_A-140 - Reflected Ceiling Plan.dwg

Permit-Seal

Client/Project

RICHMOND UNIVERSITY MEDICAL CENTER
TRANSFORMATION GRANT
669 CASTLETON AVE, STATEN ISLAND, NY
SECOND FLOOR PROPOSED RENOVATION

Title

SECOND FLOOR
REFLECTED CEILING PLAN

Project No. 225300004 Scale AS NOTED

Drawing No. Sheet Revision


A-140.00 16 of 22

GENERAL NOTES:

- CONTRACTOR SHALL COORDINATE WITH ELECTRICAL DRAWING FOR SPECIFIC LIGHT FIXTURE TYPES AND QUANTITIES.
- CONTRACTOR SHALL COORDINATE LOCATION OF H.V.A.C. DUCTWORK AND PIPING WITH MECHANICAL DRAWINGS.
- CONTRACTOR SHALL FURNISH AND INSTALL CONTINUOUS METAL TRIM (WHITE WITH FACTORY APPLIED PAINT FINISH) AT ALL PIPE, CONDUIT & DUCT PENETRATIONS THROUGH CEILING CONSTRUCTION.
- ALL ELECTRICAL SWITCHES AND COVER PLATES SHALL BE MOUNTED VERTICALLY, STRAIGHT AND ALIGNED, AND SHALL MATCH SPEC INFO AS NOTED.
- USE BUILDING APPROVED FASTENERS WHEN SECURING BLACK IRON OR CEILING SUSPENSION RODS TO UNDERSIDE OF DECK ABOVE.
- ALL SWITCHES IN A GROUP ARE TO BE GANGED WHERE POSSIBLE WITH A SINGLE COVER PLATE.
- PROVIDE MINIMUM OF (1) ONE LIGHT SWITCH PER ROOM U.O.N.
- ANY ADDITIONAL EQUIPMENT NEED FOR INSTALLATION OF THE SPECIFIED FIXTURES SHALL BE PROVIDED BY THE CONTRACTOR.
- ANY NECESSARY GRID LOCATION CHANGES OR FIXTURE LOCATION CHANGES SHALL BE APPROVED BY THE ARCHITECT PRIOR TO INSTALLATION.
- CONTRACTOR TO FINISH AND INSTALL FIRE AND SMOKE DAMPERS AS NECESSARY IN NEW AND EXISTING DUCTWORK TO ACHIEVE REQUIRED FIRE COMPARTMENTALIZATION.
- FOR EXTENT OF EXISTING DUCTWORK TO REMAIN, SEE MECHANICAL DRAWINGS.
- EXISTING FIRE PROTECTION AND LIFE SAFETY DEVICES, INCLUDING SPEAKERS, STROBES, EMERGENCY FIXTURES, EXIT LIGHTS, SMOKE DETECTORS AND SPRINKLERS TO BE REUSED TO FULLEST EXTENT POSSIBLE.

LEGEND:

- OFFICE - ROOM NAME
 - XXX - ROOM NUMBER
 - 8'-0" - CEILING HEIGHT
 - ACT/GYP, BD. - CEILING TYPE
 - NEW GYP. BD. CEILING/ SOFFIT
 - NEW LAY-IN CEILING TILE AND GRID
 - EXISTING LAY-IN CEILING TILE AND GRID TO REMAIN; REPLACE TILES WITH NEW
 - REPAIR OF EXISTING LAY-IN CEILING GRID MAY BE REQUIRED
 - F1 - NEW 2' X 2' LED LIGHT FIXTURE
 - F2 - NEW 4" DIA. LED DOWNLIGHTS
 - F3 - NEW 2' X 4' LED LIGHT FIXTURE
 - F4 - NEW 2' PENDANT LED FIXTURE
 - NC - NC DOME LIGHT
 - NEW RETURN REGISTER
 - NEW SUPPLY DIFFUSER
 - NEW SPRINKLER HEAD
 - SMOKE DETECTOR
- REFER TO FINISH SCHEDULE FOR MORE INFORMATION
- REFER TO ELECTRICAL DRAWINGS FOR MORE INFORMATION
- REFER TO HVAC, FP, FA DWGS FOR MORE INFORMATION

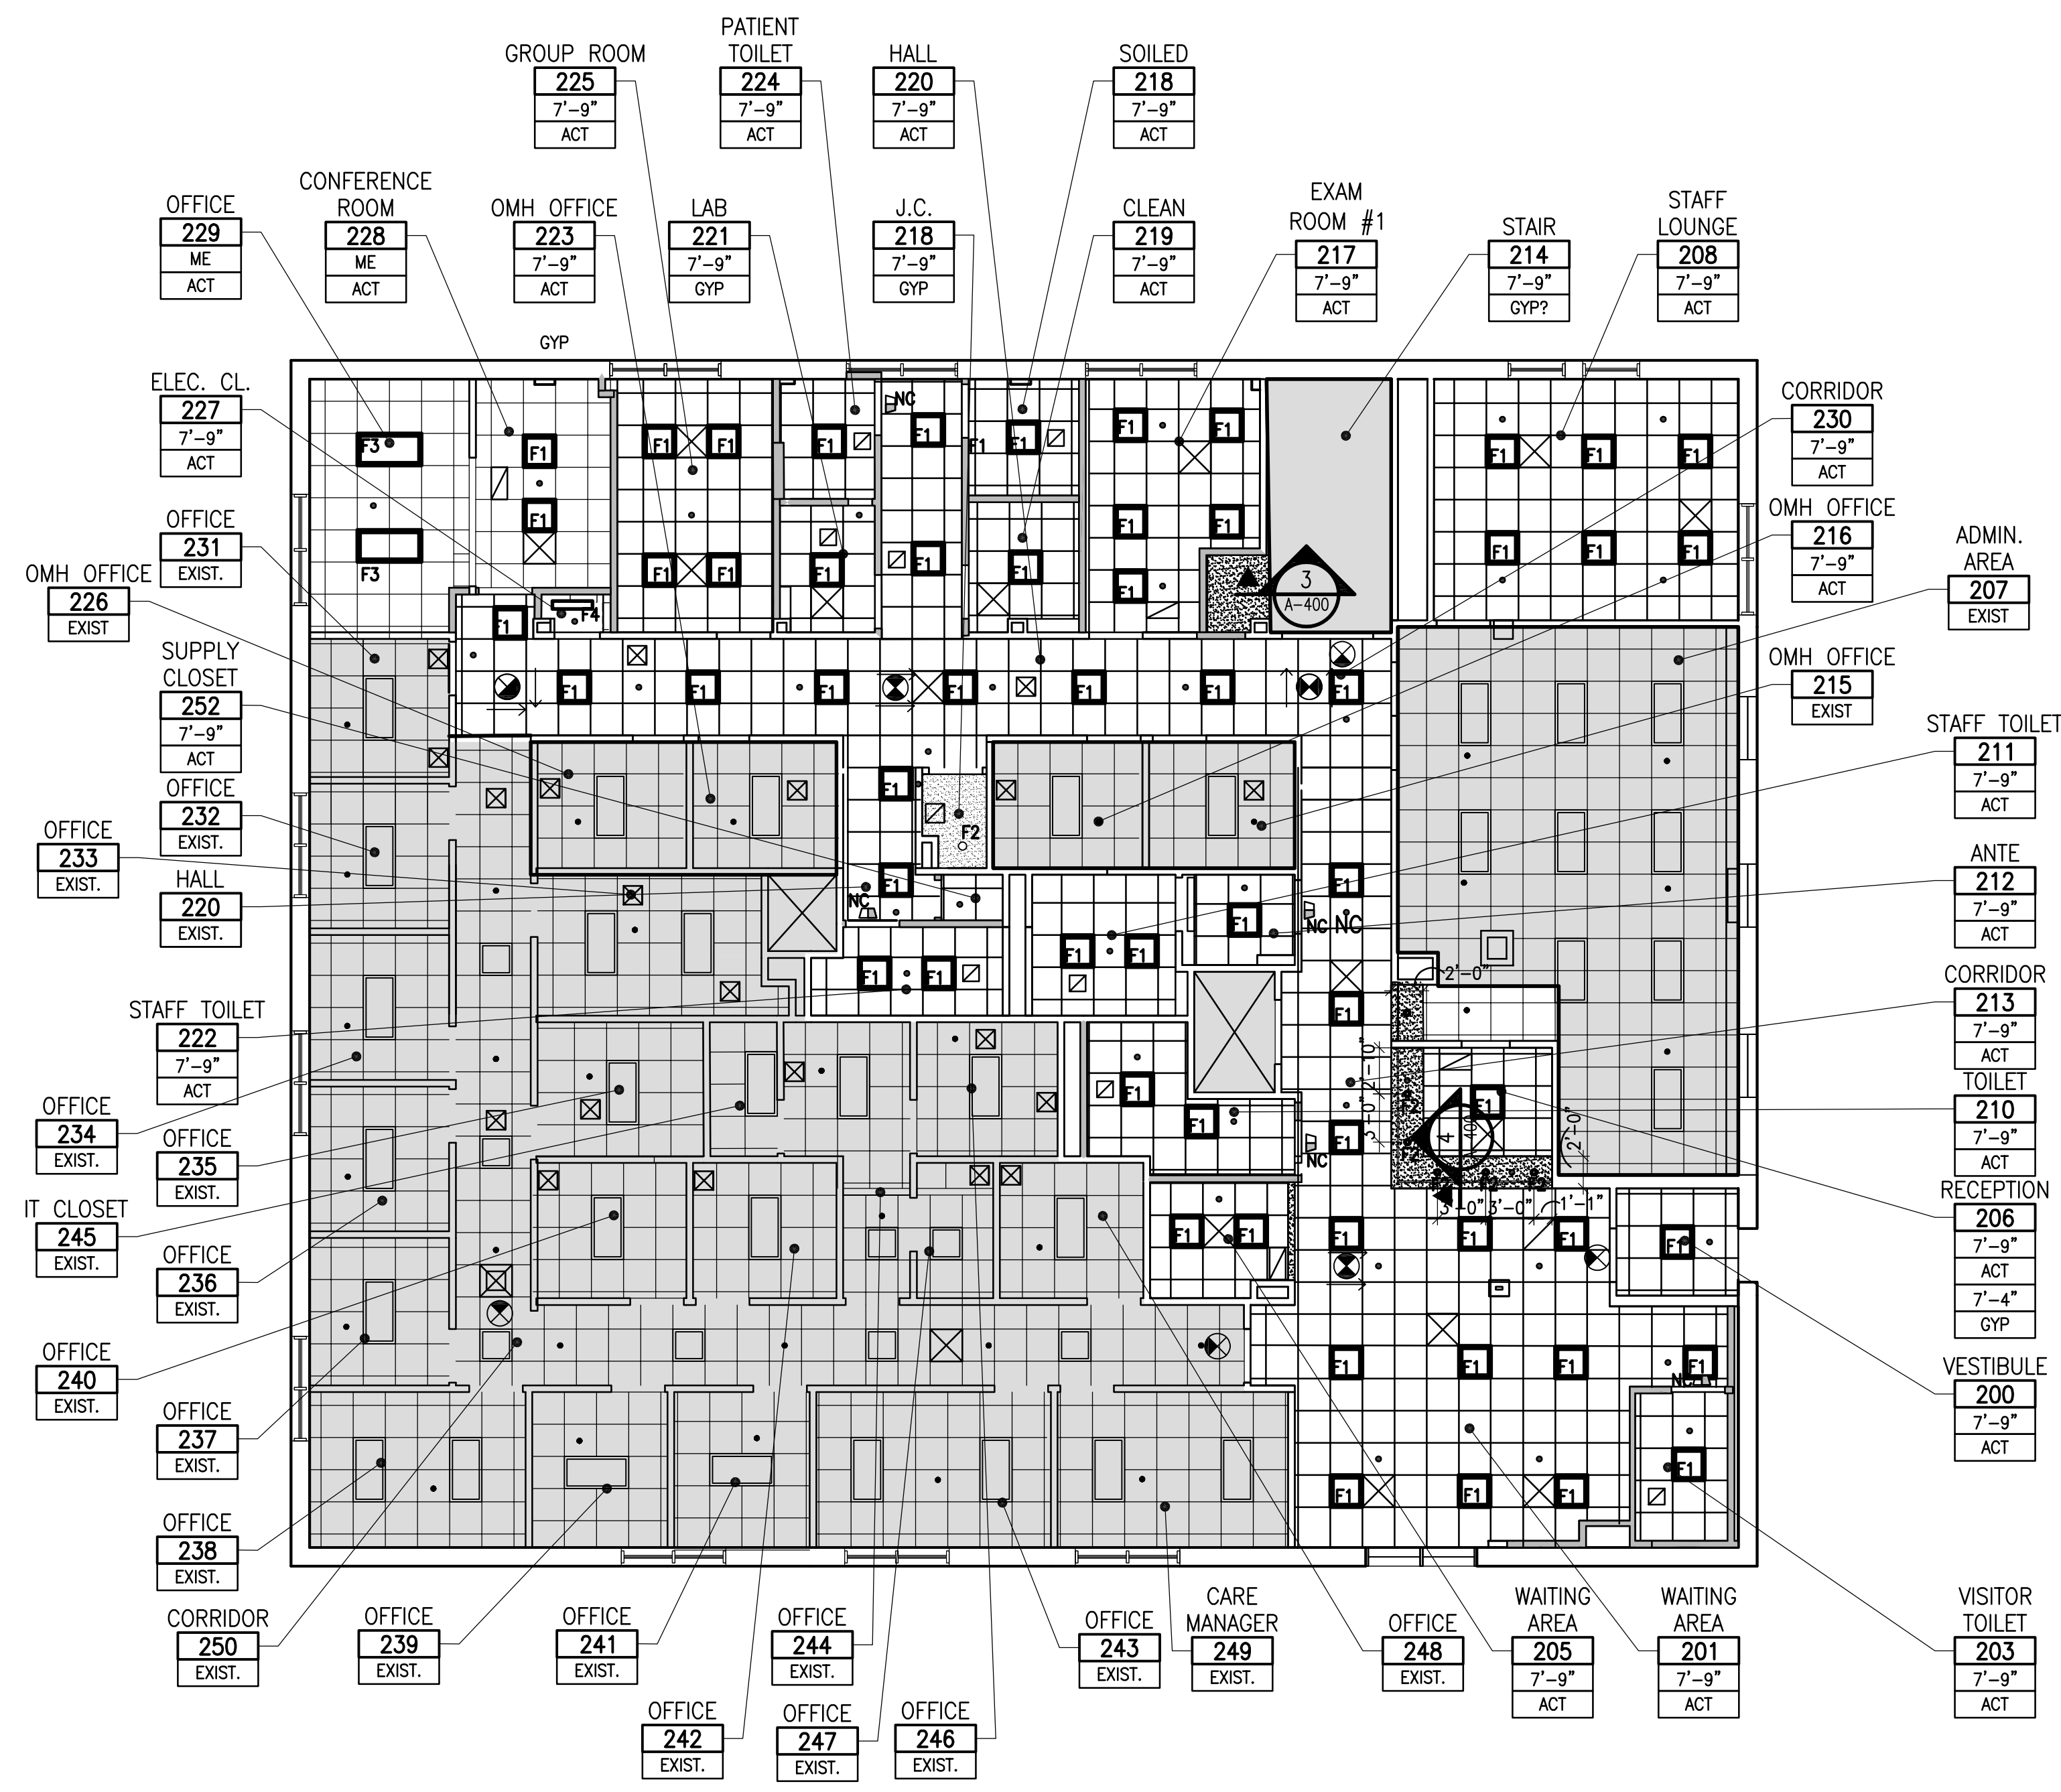

SECOND FLOOR REFLECTED CEILING PLAN

SCALE: 1/8" = 1'-0"